


CLIENT NAME HERE

LEGEND

- ⊕ 110 WALL OUTLET
- ⊕ 6.F.I. OUTLET
- ⊕ 220 ELEC. OUTLET
- ⊕ 110 LIGHT SWITCH
- ⊕ CABLE T.V. OUTLET
- ⊕ TELEPHONE JACK
- ⊕ ELEC. METER BASE
- ⊕ EXTERIOR LIGHT FIXTURE
- ⊕ CEILING MOUNT LIGHT FIXTURE
- ⊕ VENTED LIGHT FIXTURE
- ⊕ RECESSED LIGHT FIXTURE
- ⊕ SMOKE DETECTOR (BATTERY BACK-UP)
- ⊕ EXTERIOR FLOOD LAMP

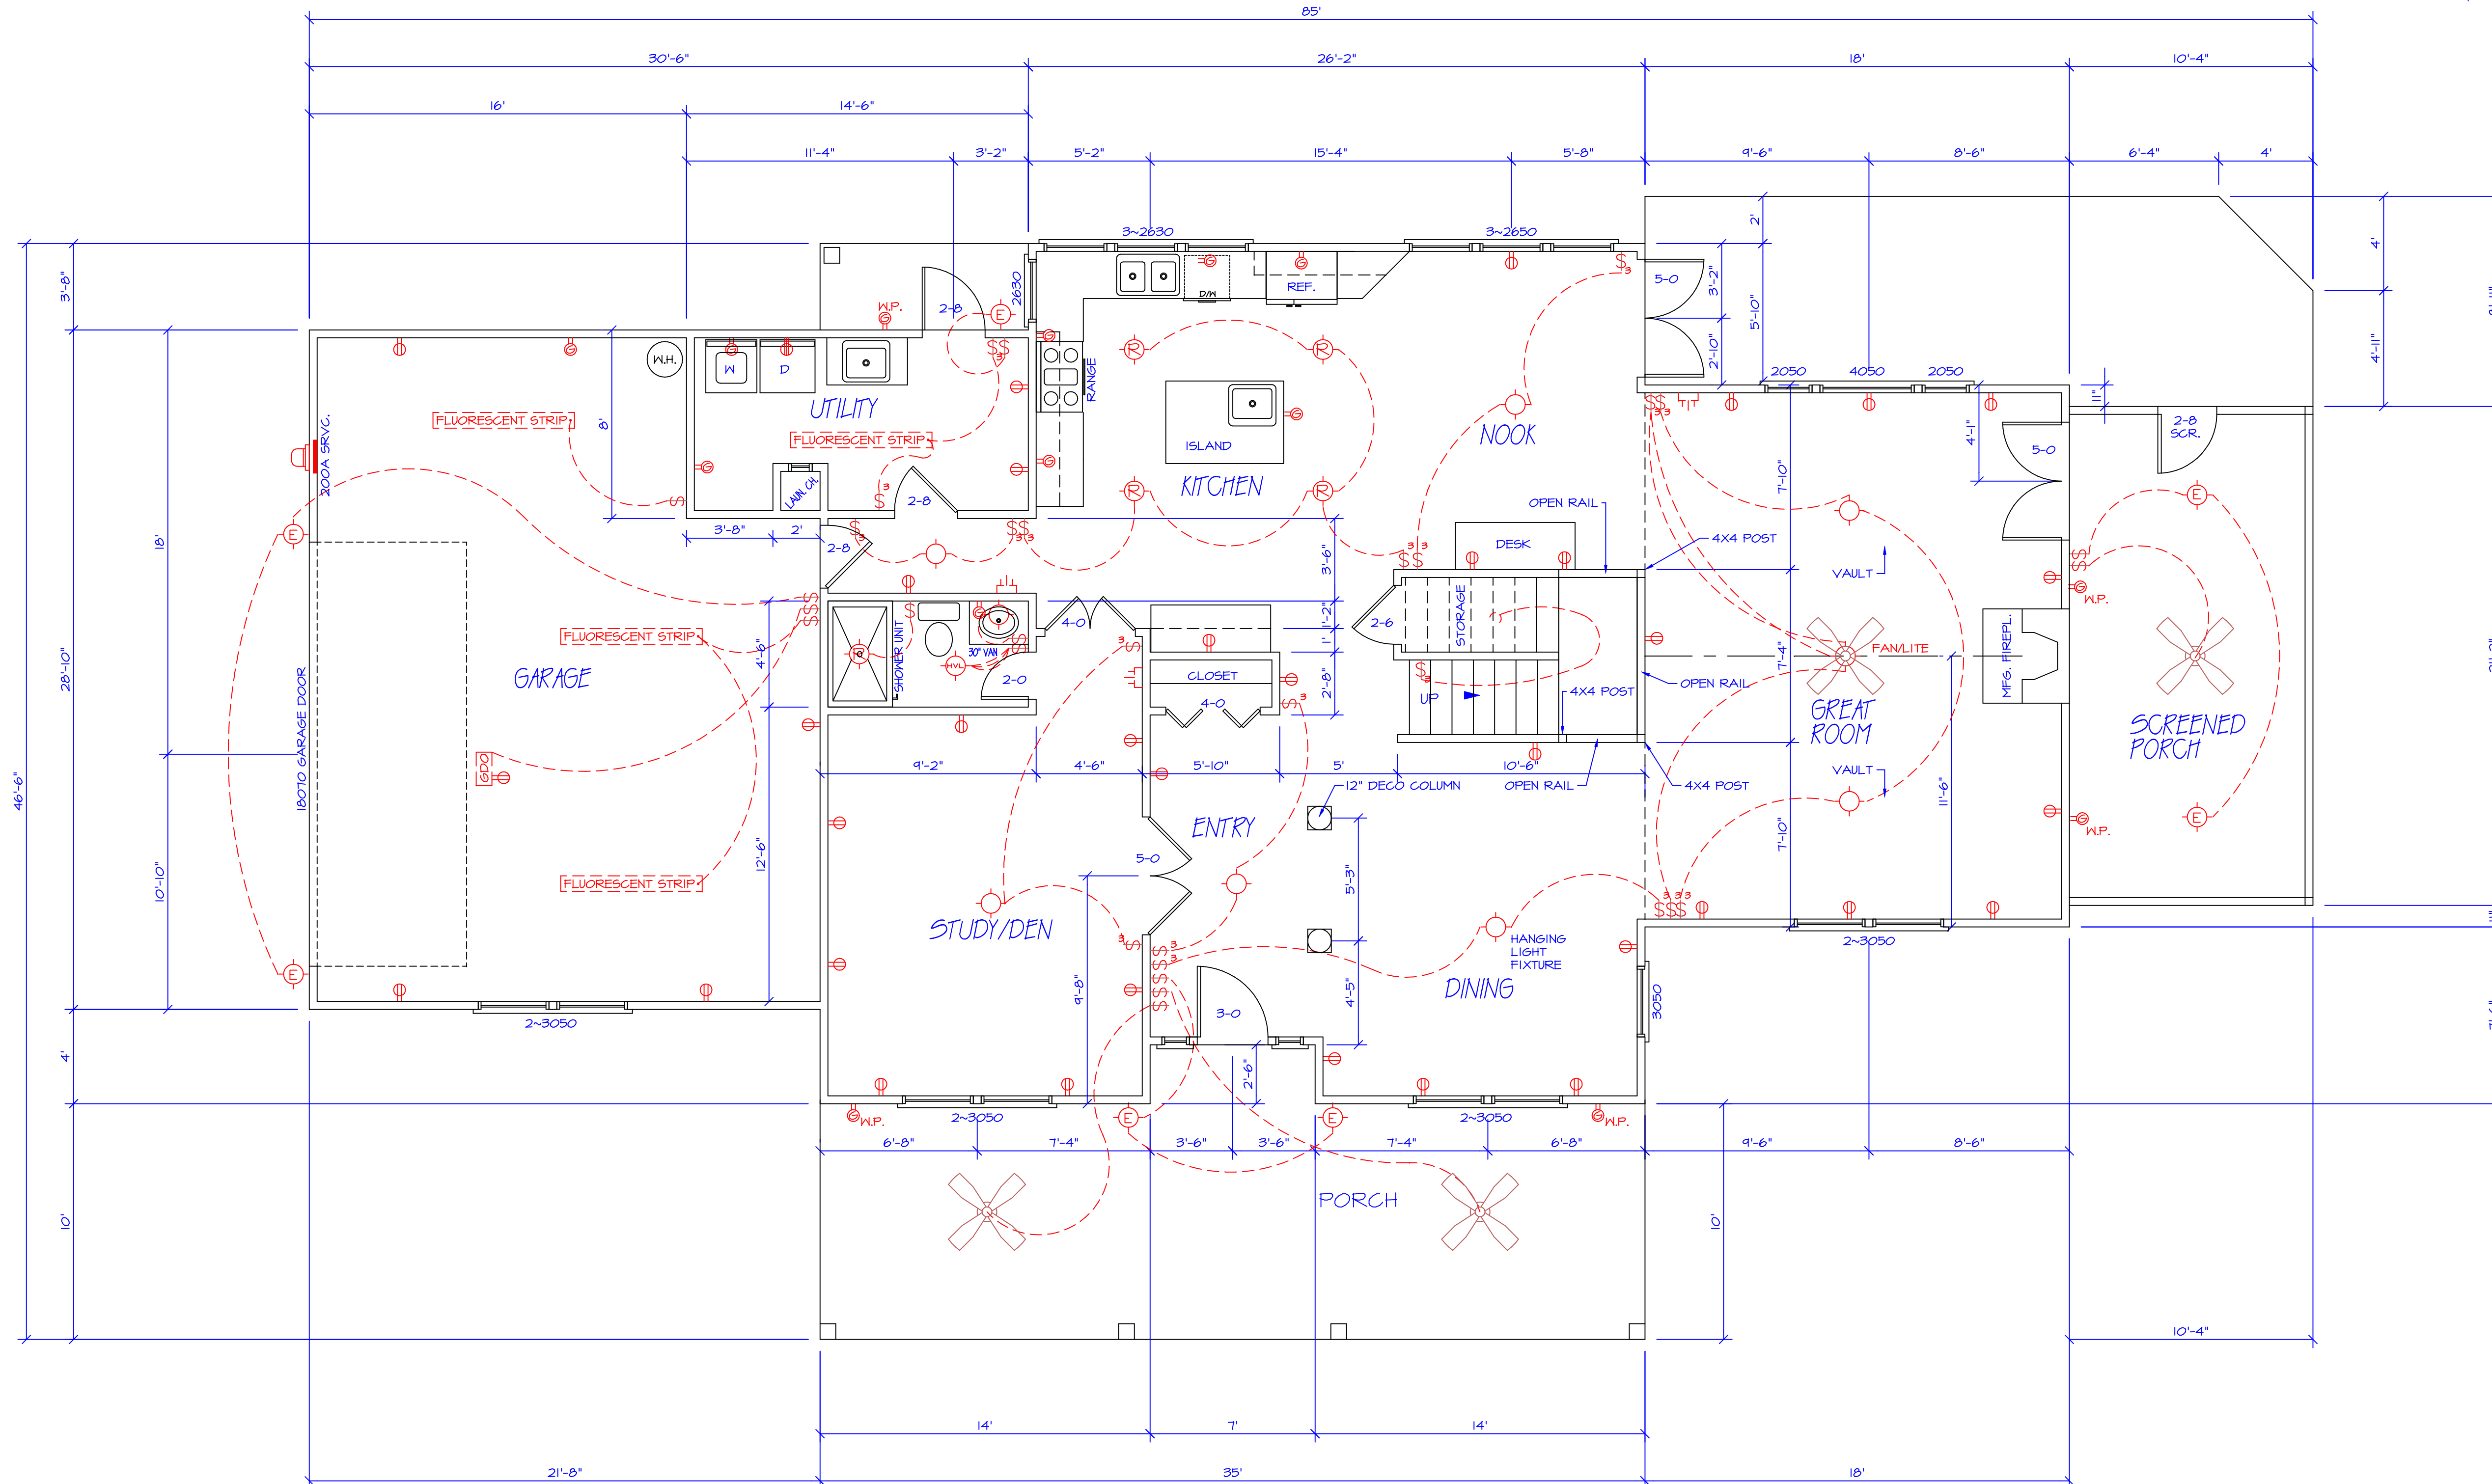

FIRST FLOOR PLAN

SCALE: 1/4" = 1'-0"  
(4' CEILINGS)

1st FLOOR SQUARE FEET HEATED = 1604  
2nd FLOOR SQUARE FEET HEATED = 1460  
TOTAL SQUARE FEET HEATED = 3064

SHEET 1 OF 4

**DRAFTING CONSULTANTS**  
 541 COUNTY ROAD 130  
 ATHENS, TENNESSEE 37303  
 (423) 381-4671