


LEGEND

- ⊕ 110 WALL OUTLET
- ⊕ G.F.I. OUTLET
- ⊕ 220 ELEC. OUTLET
- ⊕ 110 LIGHT SWITCH
- ⊕ CABLE T.V. OUTLET
- ⊕ TELEPHONE JACK
- ⊕ ELEC. METER BASE
- ⊕ EXTERIOR LIGHT FIXTURE
- ⊕ CEILING MOUNT LIGHT FIXTURE
- ⊕ HEATED & VENTED LIGHT FIXTURE
- ⊕ RECESSED LIGHT FIXTURE
- ⊕ SMOKE DETECTOR (BATTERY BACK-UP)
- ⊕ EXTERIOR FLOOD LAMP
- ⊕ CEILING FAN WITH LIGHT
- ⊕ 48" 2-BULB FLUORESCENT STRIP LIGHT


IT IS THE INTENT OF THESE DOCUMENTS TO PROVIDE SUFFICIENT INFORMATION TO THE EXPERIENCED BUILDER TO CONSTRUCT THE PROJECT SHOWN. IT IS THEREFORE HIS RESPONSIBILITY TO VERIFY ACCURACY AND COMPLIANCE WITH ALL REGULATORY AGENCIES PRIOR TO CONSTRUCTION. THEIR REQUIREMENTS MUST TAKE PRECEDENCE OVER THOSE SHOWN AND FIELD ADJUSTMENTS MADE ACCORDINGLY.....

THE INFORMATION CONTAINED ON THESE DOCUMENTS AND ALL RELATED DOCUMENTS SHALL BE CONSIDERED AS "PROPRIETARY INFORMATION" THE DISCLOSURE OF ANY INFORMATION, METHOD OR PROCESS DISCLOSED IN THESE DOCUMENTS WILL BE AN INFRINGEMENT UPON THIS COMPANY'S PRIVATE RIGHTS. THESE DOCUMENTS ARE NOT TO BE REPRODUCED IN ANY SHAPE, FORM OR FASHION WITHOUT WRITTEN PERMISSION OF DRAFTING CONSULTANTS OF ATHENS, TN. NAMED CUSTOMER. NO REPRESENTATION OR WARRANTY IS EXPRESSED.....

SHOULD CITY, COUNTY, STATE, OR FEDERAL LAW REQUIRE THAT THE PROJECT SHOWN SHOULD BE COMPLETED FROM START TO FINISH BY A LICENSED ARCHITECT OR ENGINEER THESE PLANS SHOULD NOT BE USED FOR CONSTRUCTION PURPOSES. DRAFTING CONSULTANTS STRONGLY SUGGESTS THAT IN SUCH A CASE THAT THESE DRAWINGS SHOULD BE USED FOR PRESENTATION PURPOSES ONLY.....

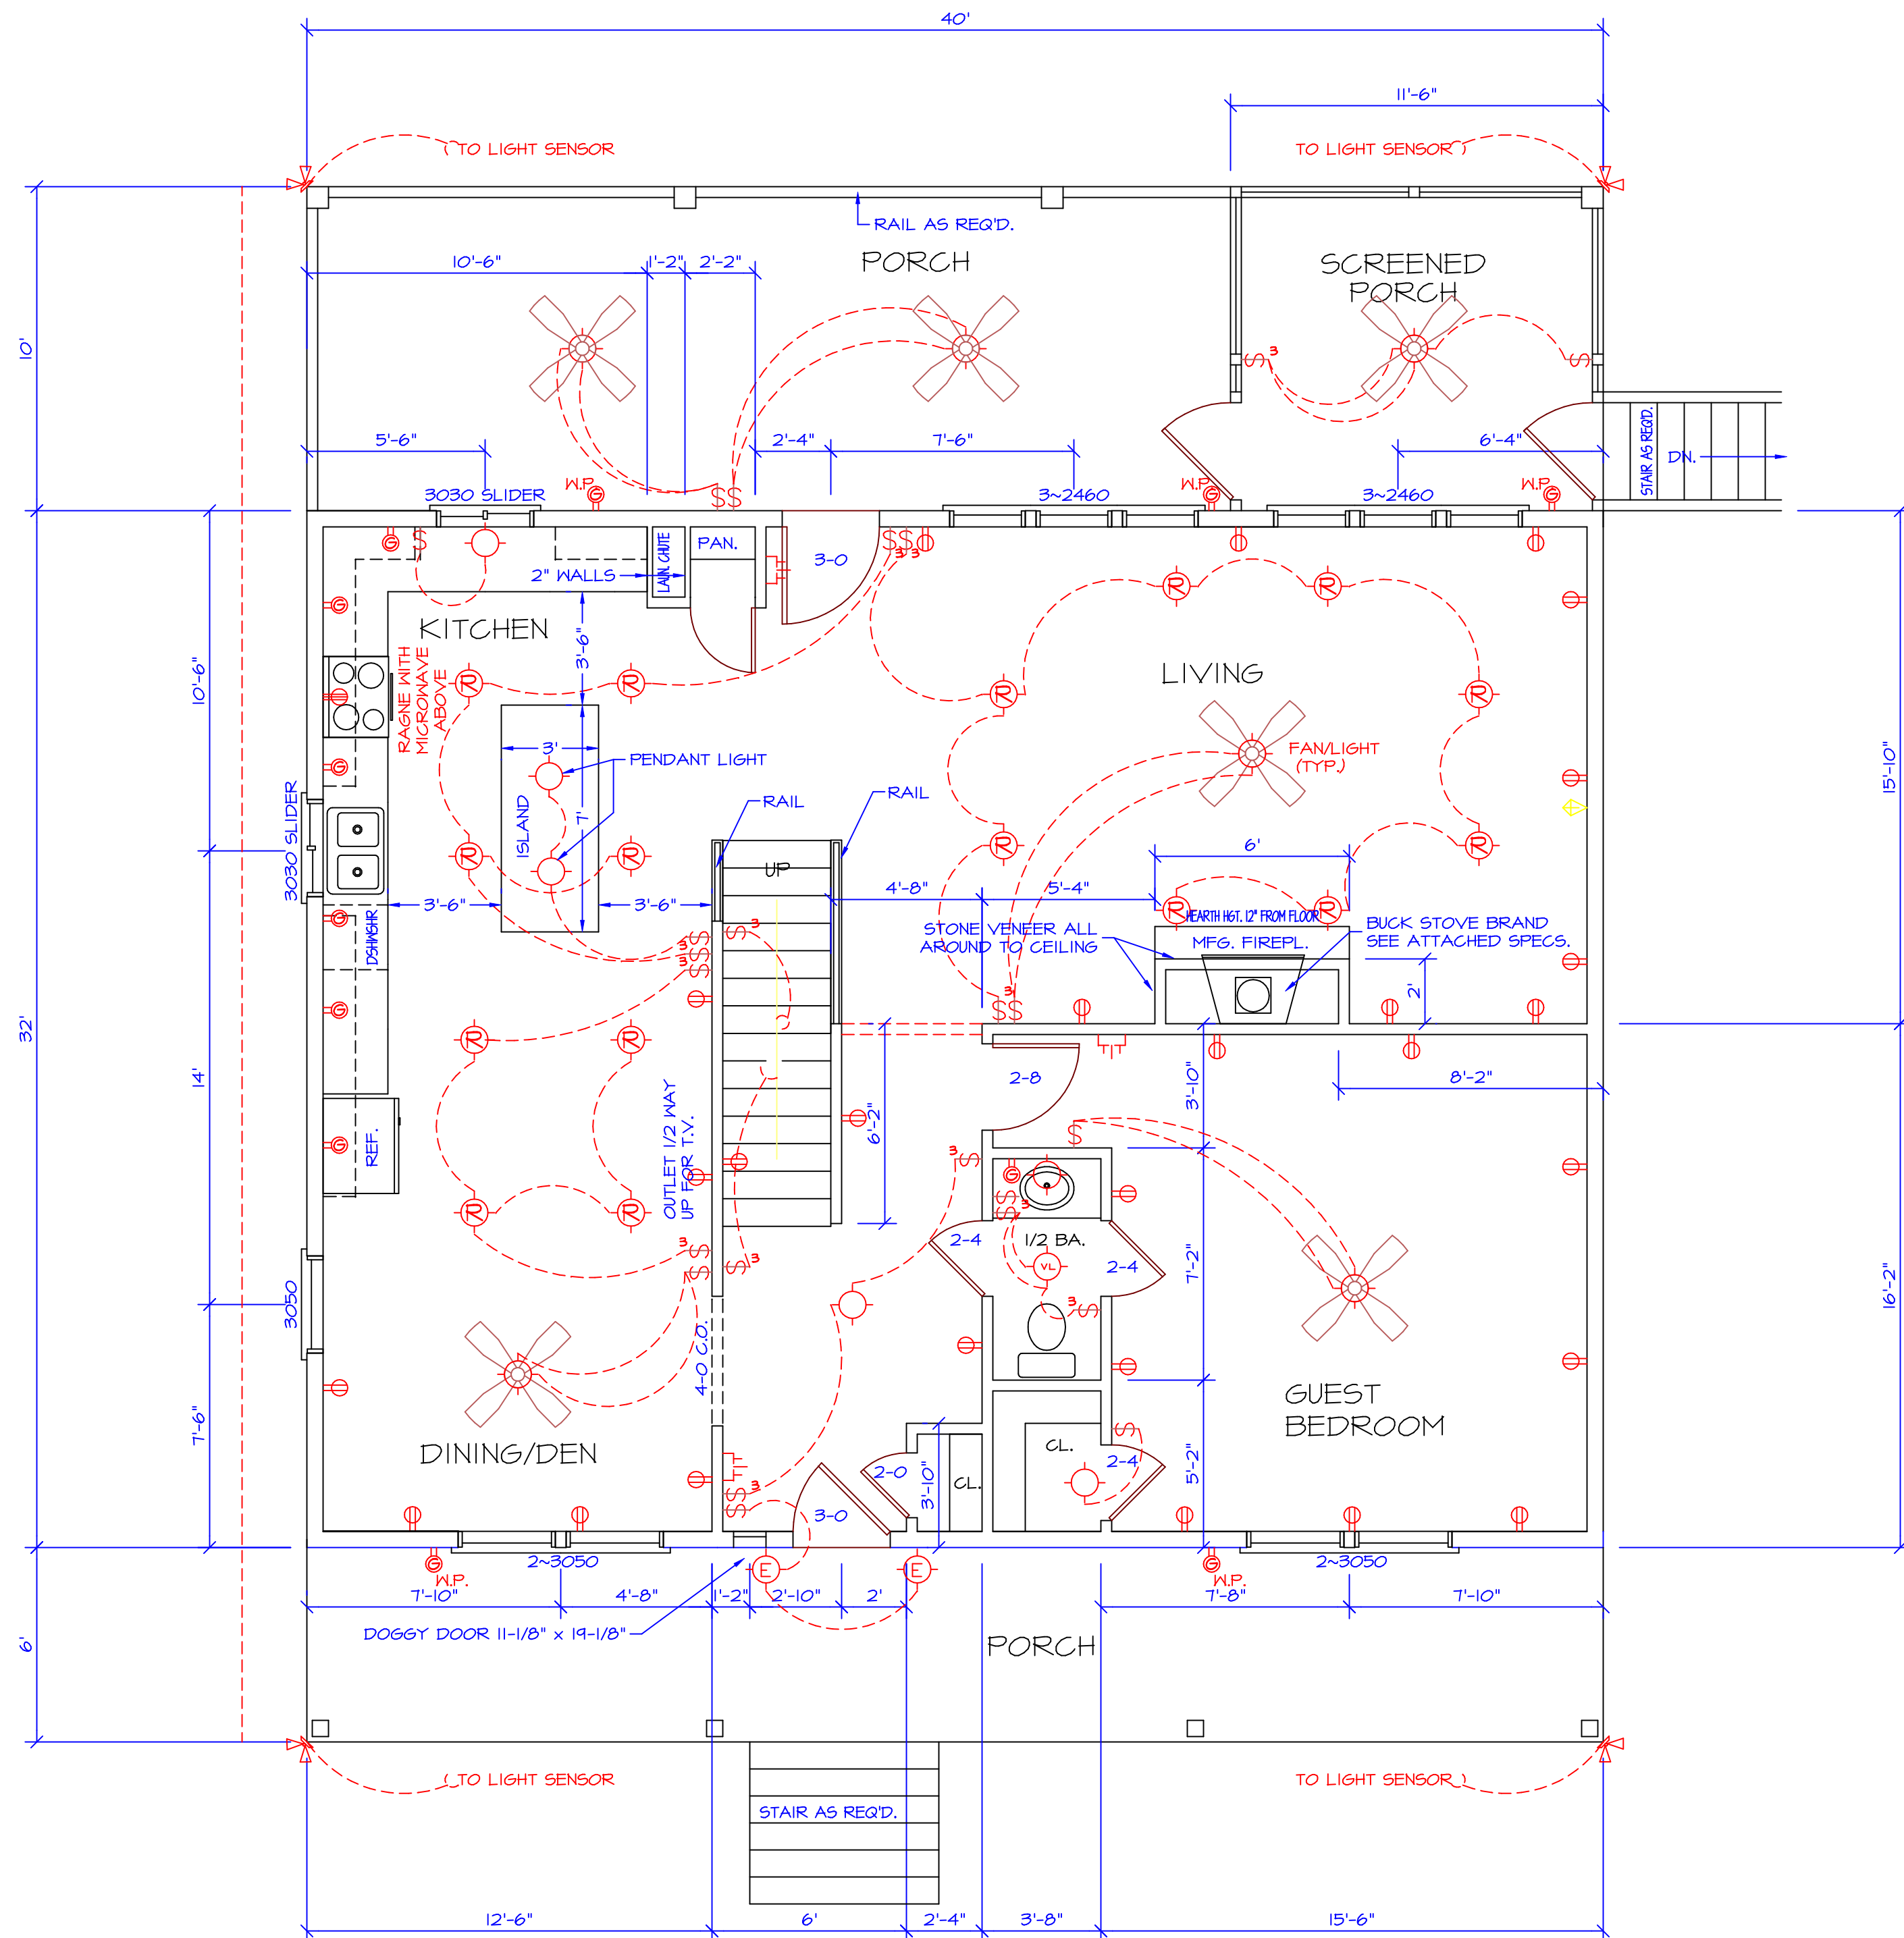

FIRST FLOOR PLAN
SCALE: 1/4" = 1' - 0"
9' CEILINGSS

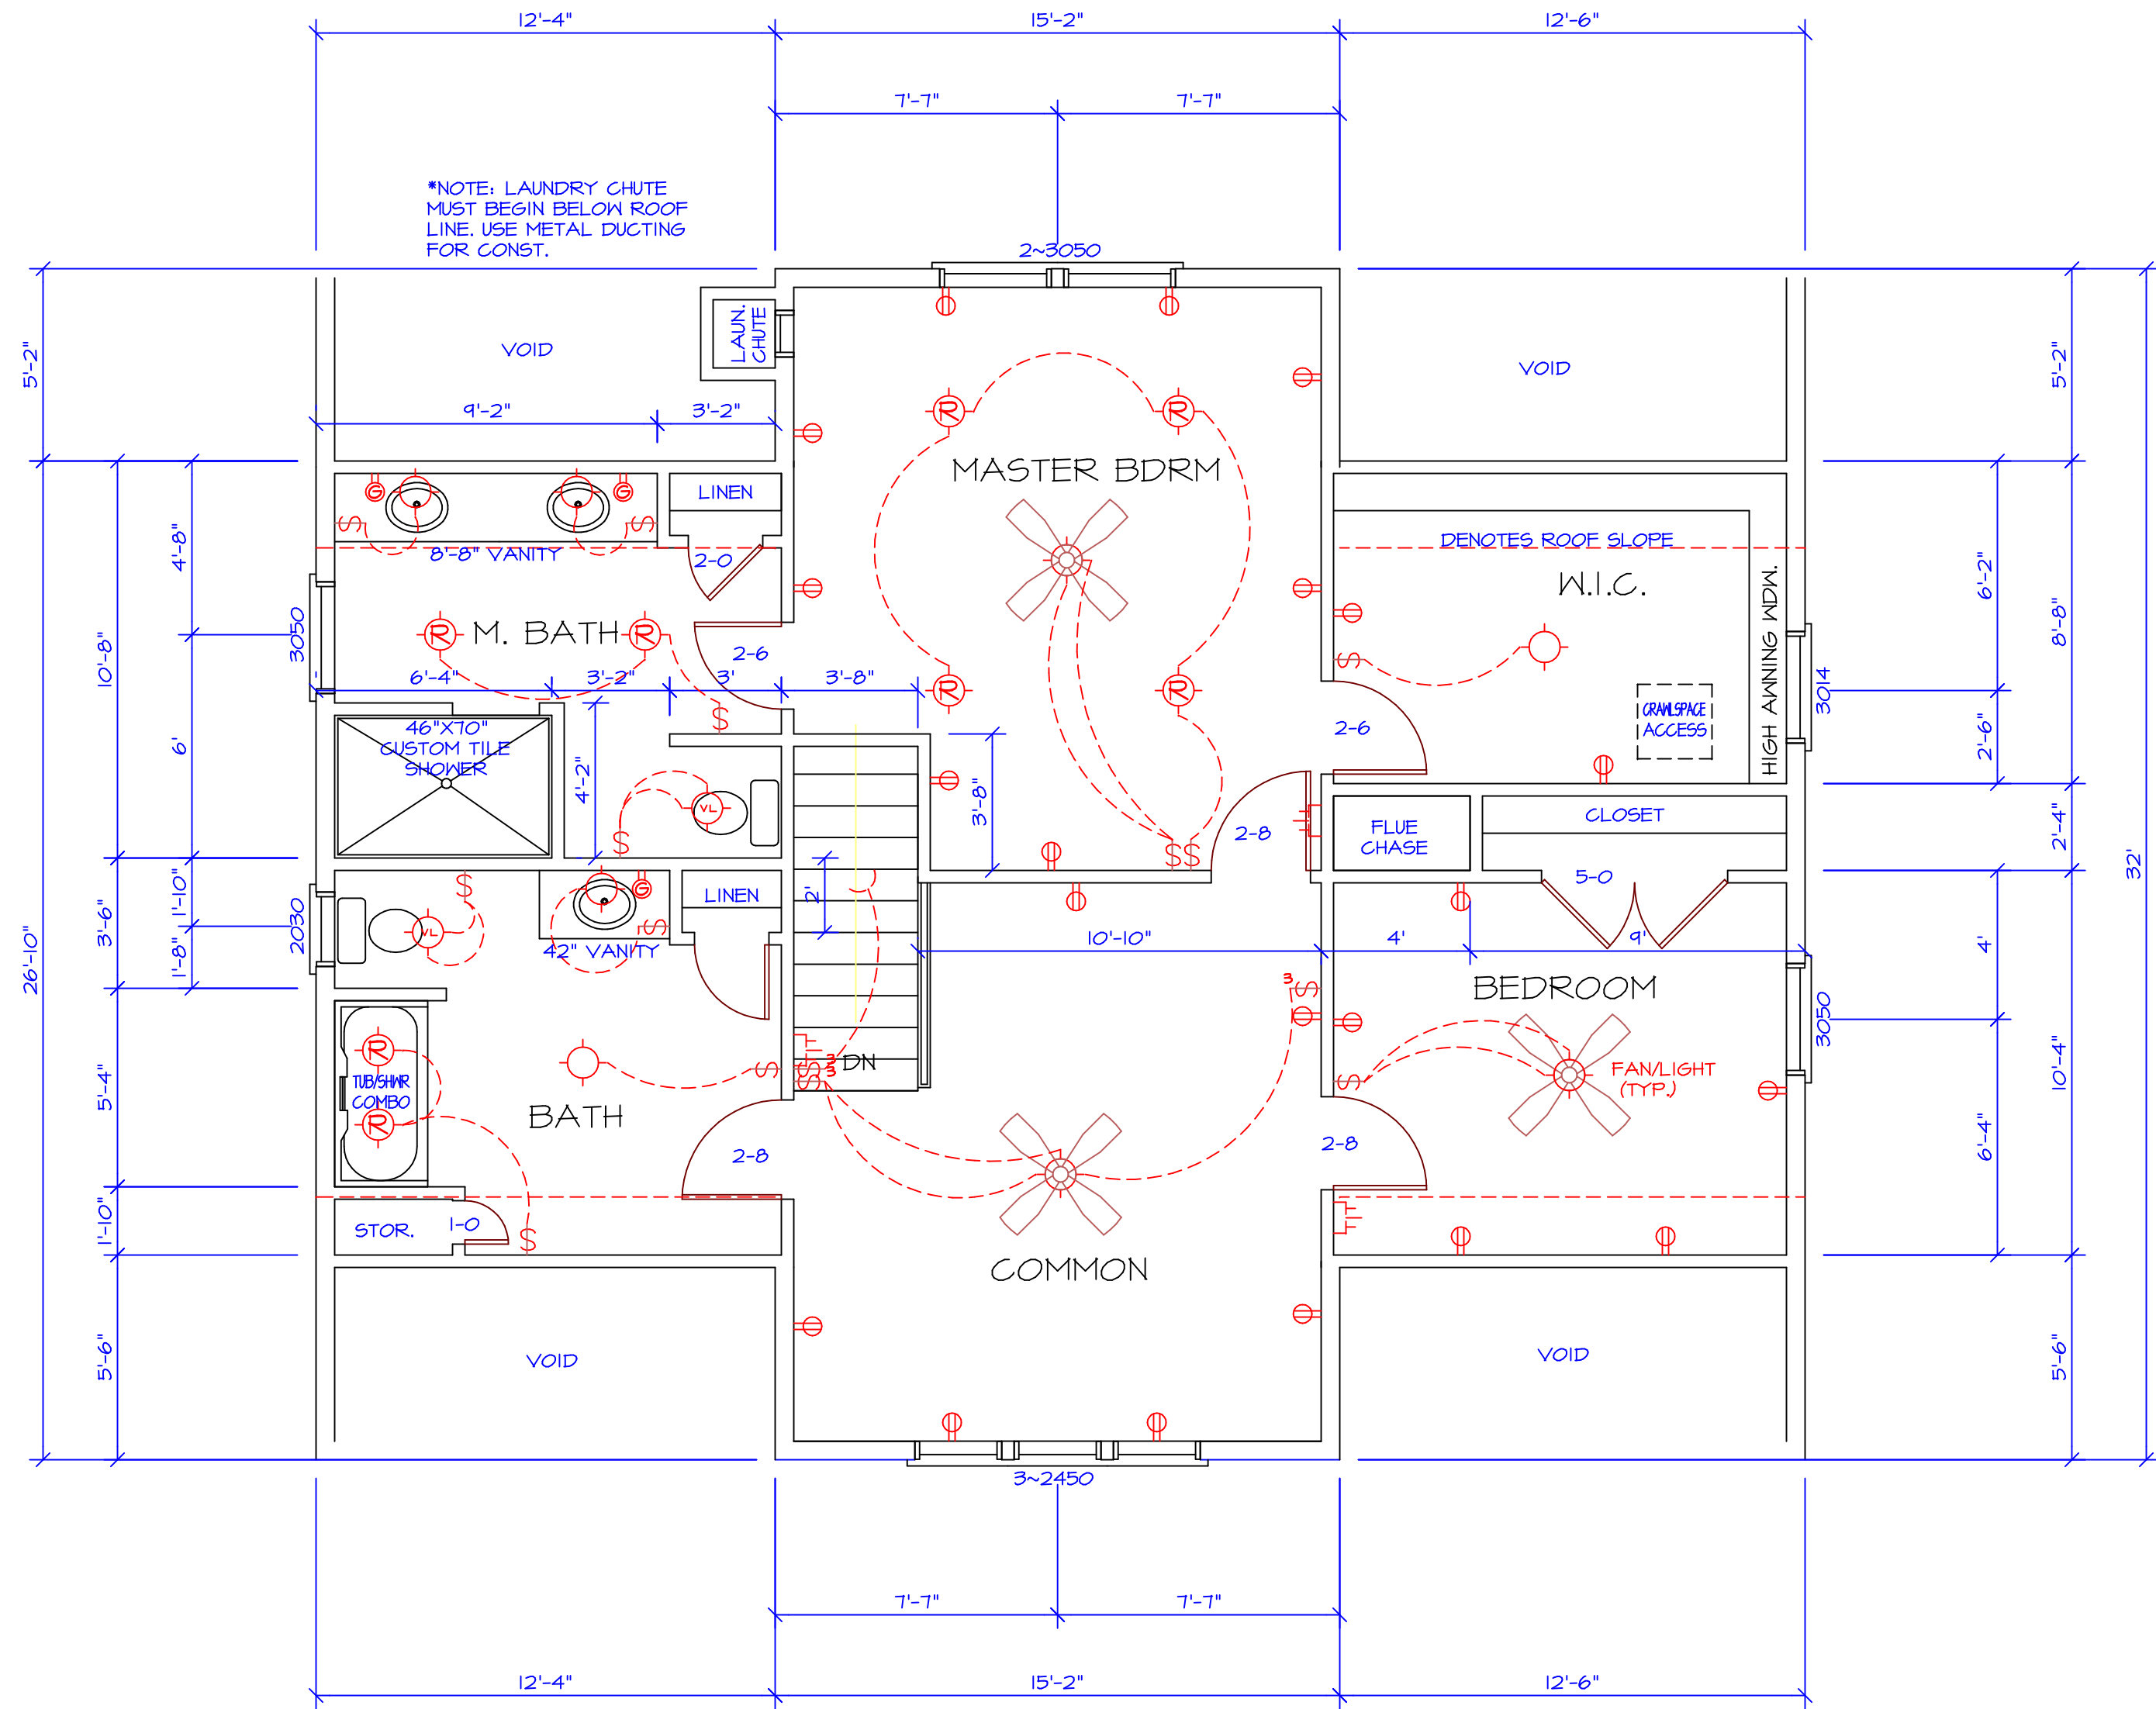

SECOND FLOOR PLAN
SCALE: 1/4" = 1' - 0"
8' CEILINGSS

MAIN FLOOR
1280 sq ft
SECOND FLOOR
1180 sq ft
BASEMENT
680 sq ft (Heated)
600 sq ft (Unheated)
**TOTAL HEATED
3140 sq ft**